




ONSITE DRAINAGE LAYOUT
1:500

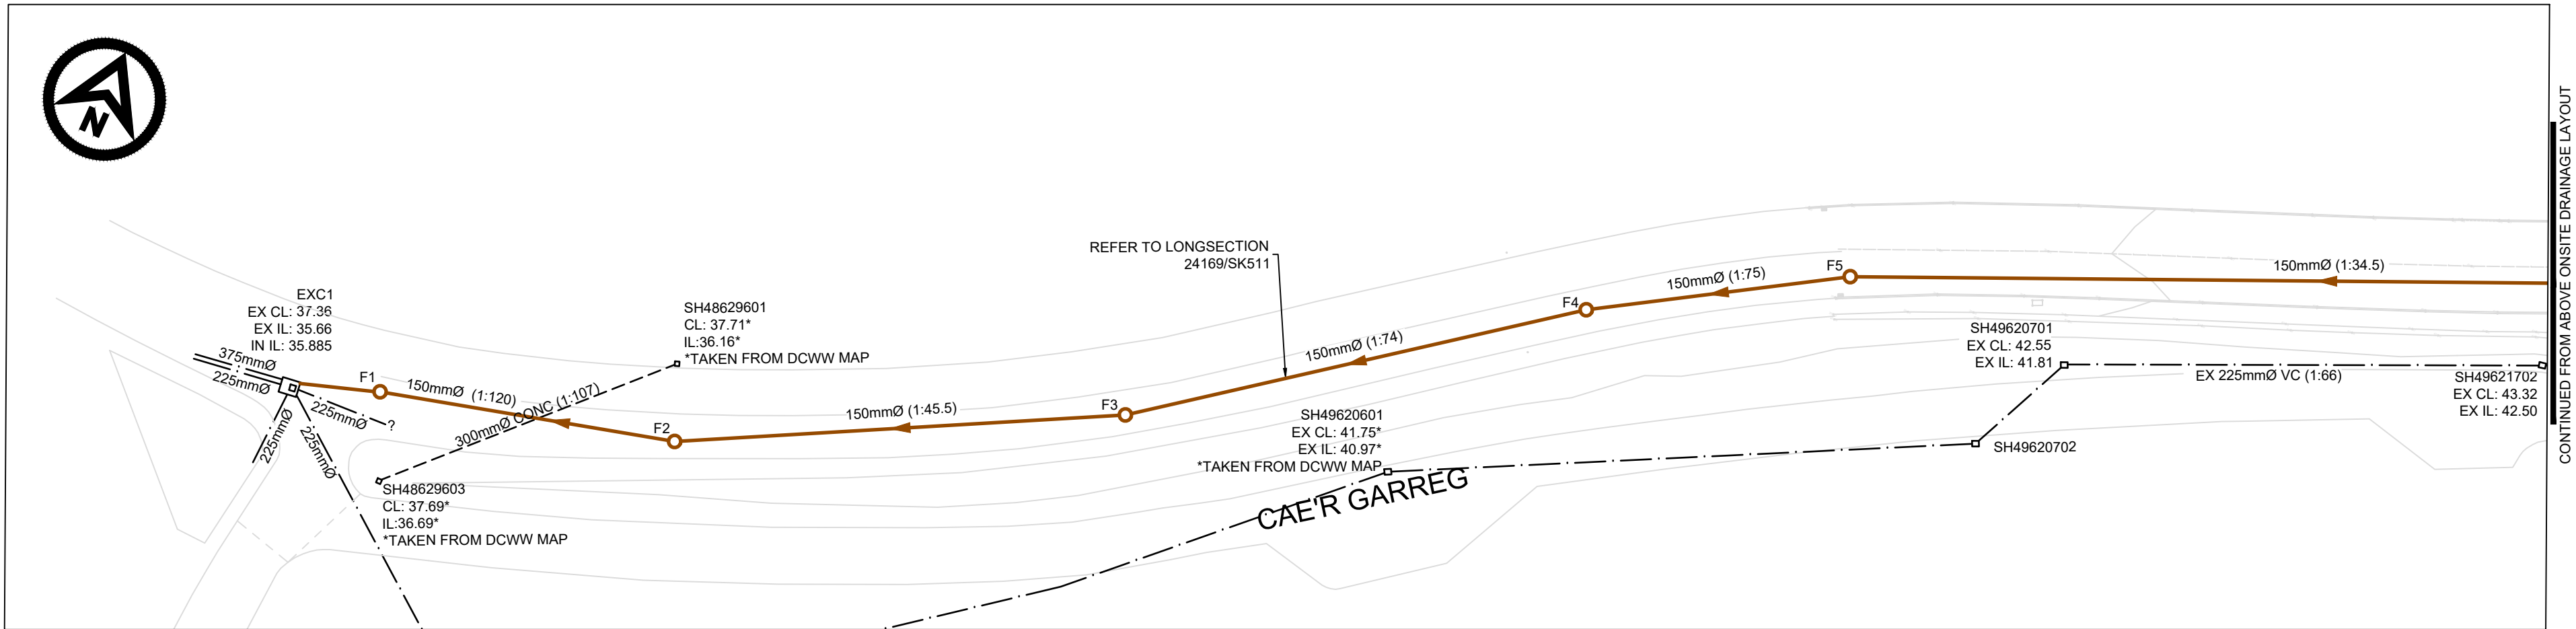

OFFSITE DRAINAGE LAYOUT
1:500

- NOTES
- THIS DRAWING IS TO BE READ IN CONJUNCTION WITH ALL RELEVANT ARCHITECT'S, ENGINEER'S AND OTHER SPECIALISTS' DRAWINGS.
 - PLEASE REFER TO ARCHITECTS DRAWINGS FOR FINAL BUILDING LOCATION
 - REFER TO DATRYS DRAWING 24169/SK511 FOR LONGSECTION

KEY

---	SITE BOUNDARY
○	EXISTING COMBINED SEWER AND CHAMBERS
---	EXISTING SURFACE WATER SEWER AND CHAMBERS
---	PROPOSED FOUL DRAINAGE AND CHAMBERS
---	PROPOSED SURFACE WATER DRAINAGE AND CHAMBERS
---	PROPOSED PERFORATED PIPE
---	PROPOSED PERMEABLE PAVING
---	PROPOSED RAINGARDEN
WB	PROPOSED WATER BUTT

REV	DATE	DESCRIPTION	BY	CHK	APP
P4	16.05.25	DRAINAGE AMENDED TO SUIT INFILTRATION RESULTS	CB	LI	NJ
P3	06.05.25	DRAINAGE AMENDED TO SUIT LAYOUT UPDATE	CB	NJ	AC
P2	19.12.24	LAYOUT AMENDED	CB	LI	AC

REVISIONS

PRELIMINARY



PROJECT

Tyddyn Fletcher,
Llanberis Road, Caernarfon.

TITLE

Foul Drainage Layout Scheme



DRAWN	CB	CHECKED	LI	PASSED	AC
DATE	30.09.24	DATRYS REF.			
SCALE AT A1	1:500	AUTOCAD REF.	24169/SK501		
DRAWING No.	24169/SK501-1	REVISION	P4		